


CONSULTANTS

Mechanical-Electrical-Plumbing
 Plant Engineering Consultants
 320 West Fillmore, Suite 100
 Colorado Springs, CO 80907
 719 473 7077

Structural
 JVS Engineering Consultants
 840 Timberline Court
 Colorado Springs, CO 80921
 719 964 6840

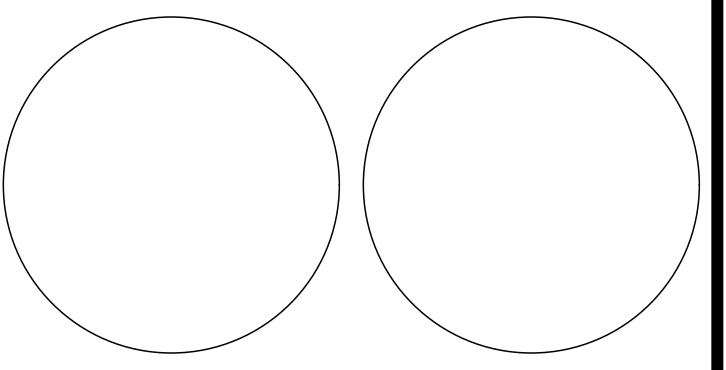

Wetmore Community Center

95 County Road 393
 Wetmore, CO 81253

NOT FOR CONSTRUCTION

Custer County

MARK	DATE	DESCRIPTION
3/3/16	ISSUED FOR PRICING	


PROJECT NO:
 MODEL FILE:
 DRAWN BY:
 CHK'D BY:
 COPYRIGHT:

SHEET TITLE
 1st FLOOR PLAN

DATE OF ISSUE: March 3, 2016

A-103

**Not a
 construction
 drawing**

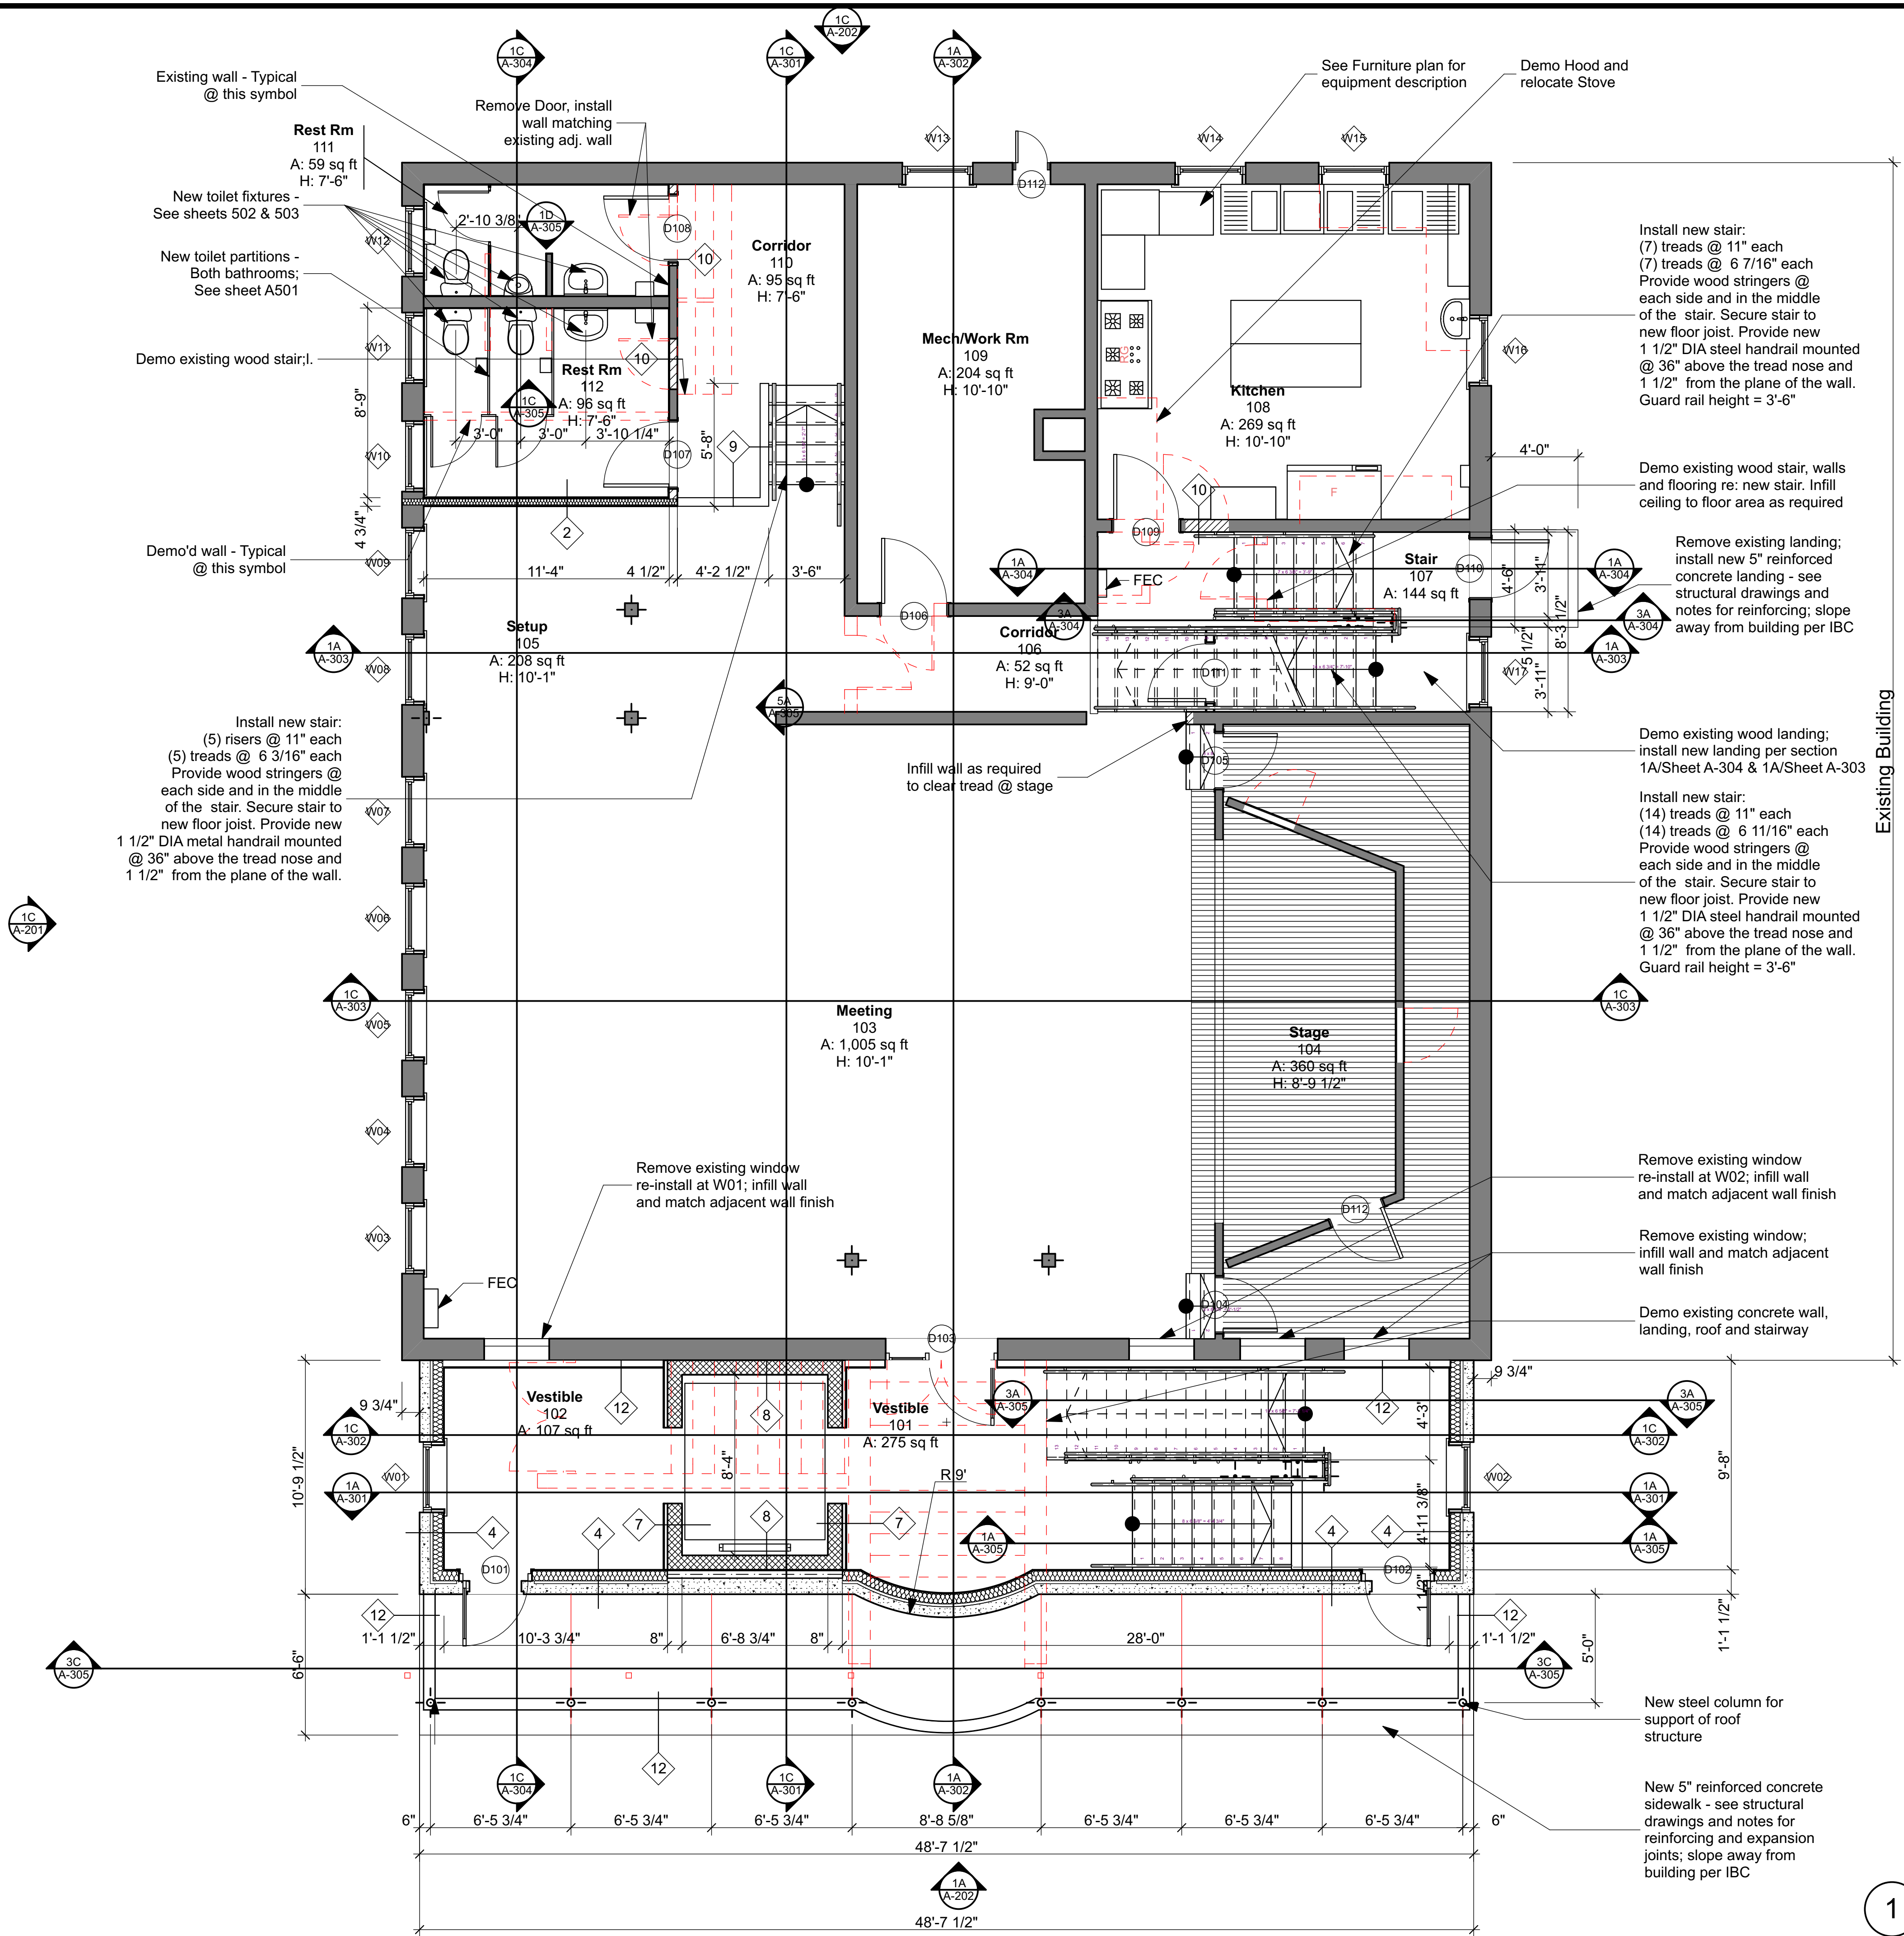


Existing Building

1A/A-201

1C/A-303

1A/A-202

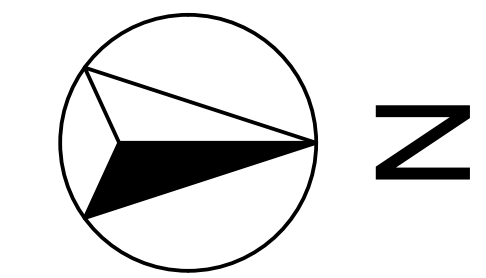

1 1st FLOOR PLAN
 SCALE: 1/4" = 1'-0"